



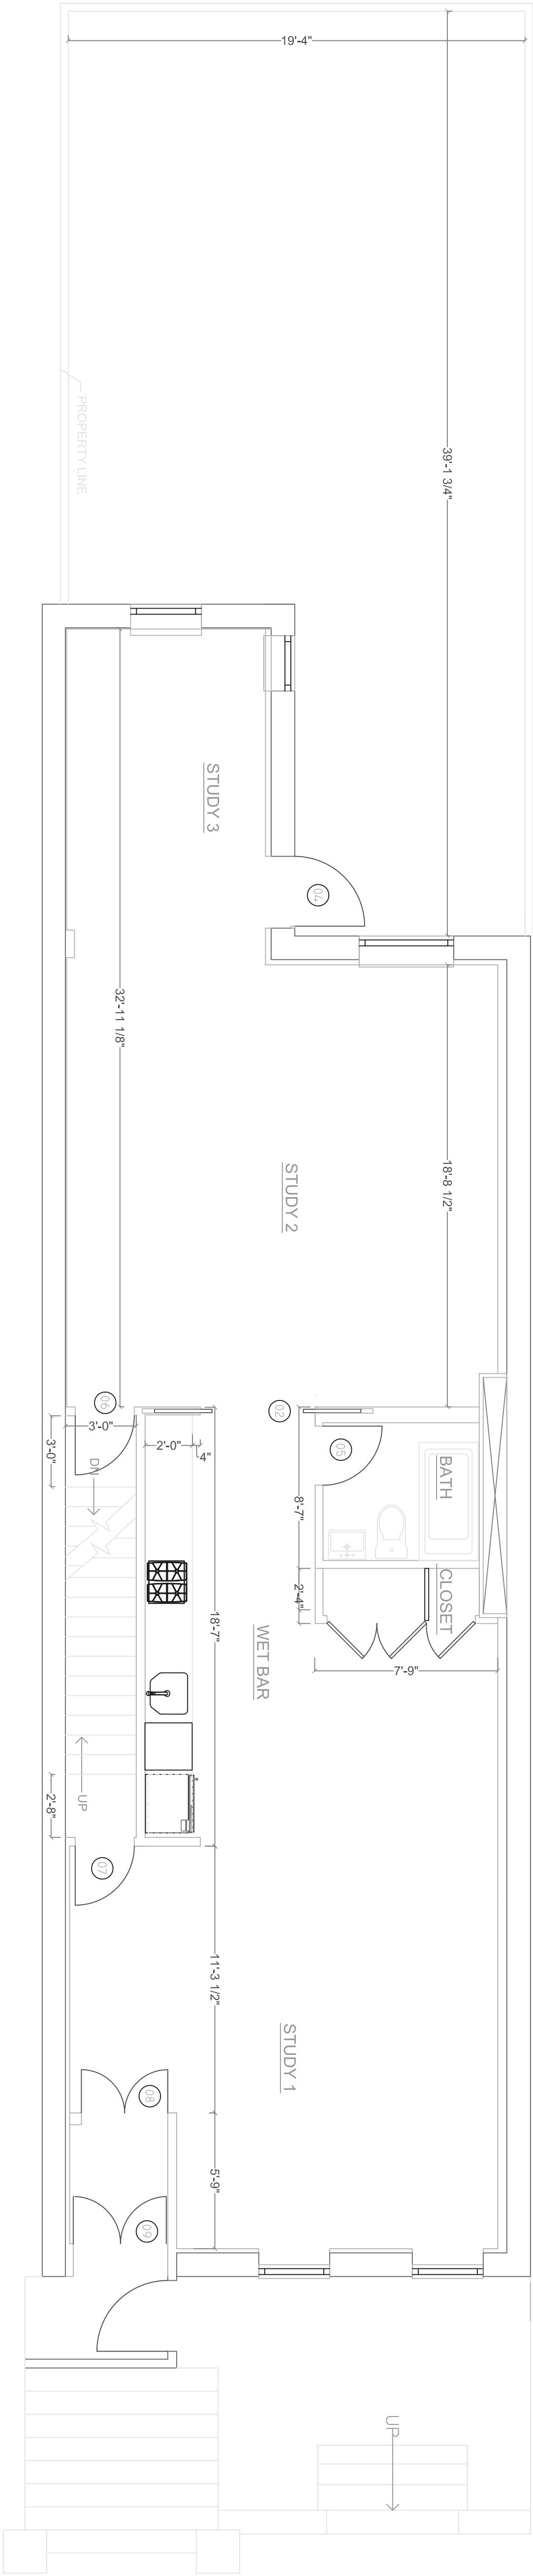


1 GARDEN FLOOR PLAN - MECHANICAL PLAN
SCALE: 1/4" = 1'-0"

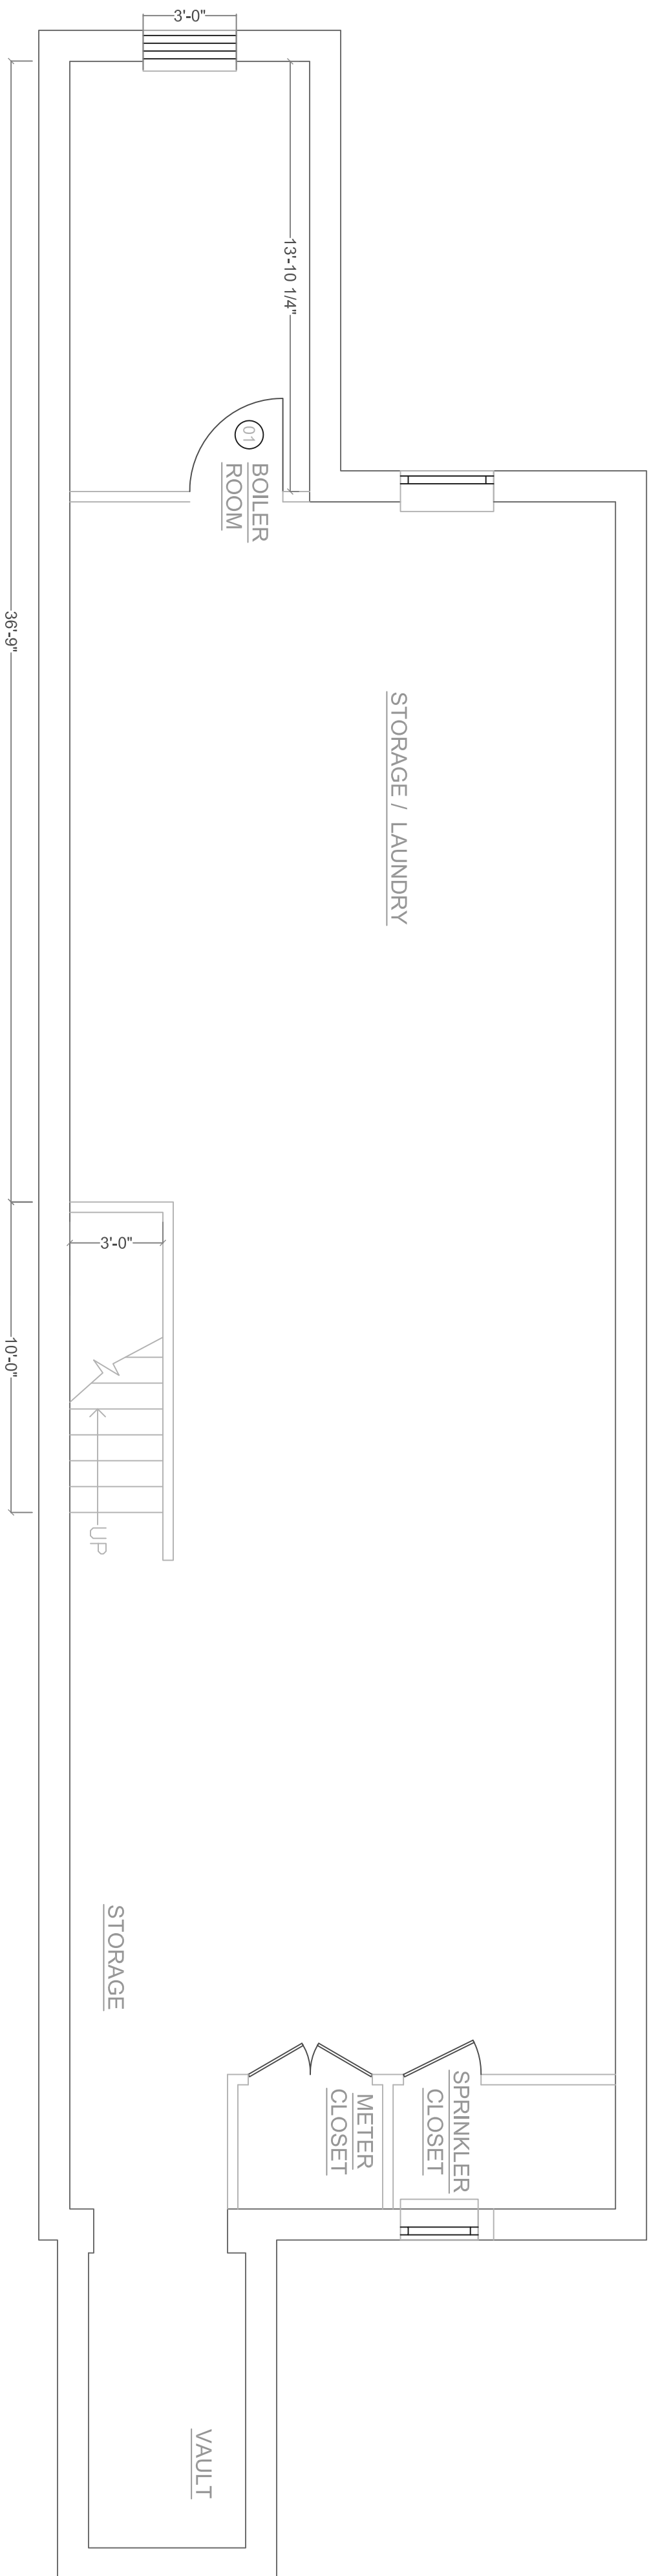


2 CELLAR FLOOR PLAN - MECHANICAL PLAN
SCALE: 1/4" = 1'-0"



NO.		DATE	REVISIONS
ΔA			
PROJECT			
RUSSELL GOSS, AIA			
LEED AP			
1123 BROADWAY			
NEW YORK, NY 10003			
P. 212.675.2658			
F. 212.675.2659			
PROJECT			
154, WEST 73RD STREET			
NEW YORK, NY 10023			
TITLE			
CELLAR AND GARDEN			
FLOOR PLAN -			
MECHANICAL PLAN			
T.I.		7 OF 10	
DATE		MC-101.00	
8.20.2012			

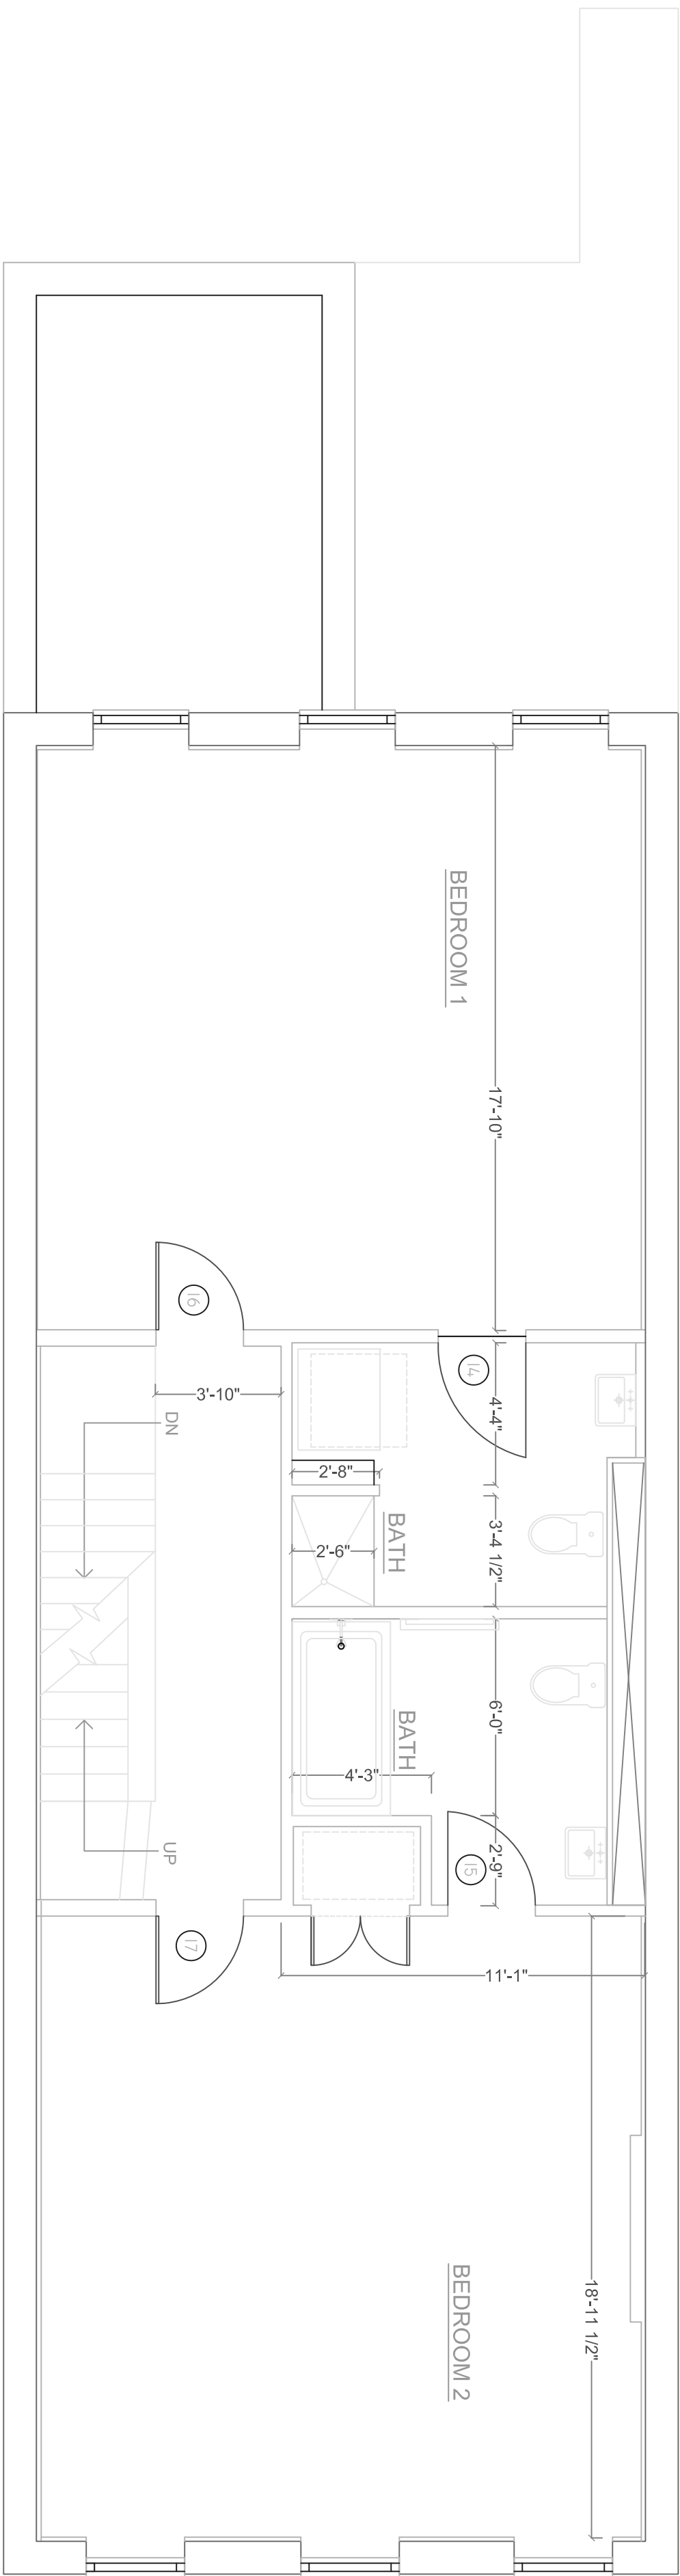


1 THIRD FLOOR PLAN - MECHANICAL PLAN
SCALE: 1/8" = 1'-0"

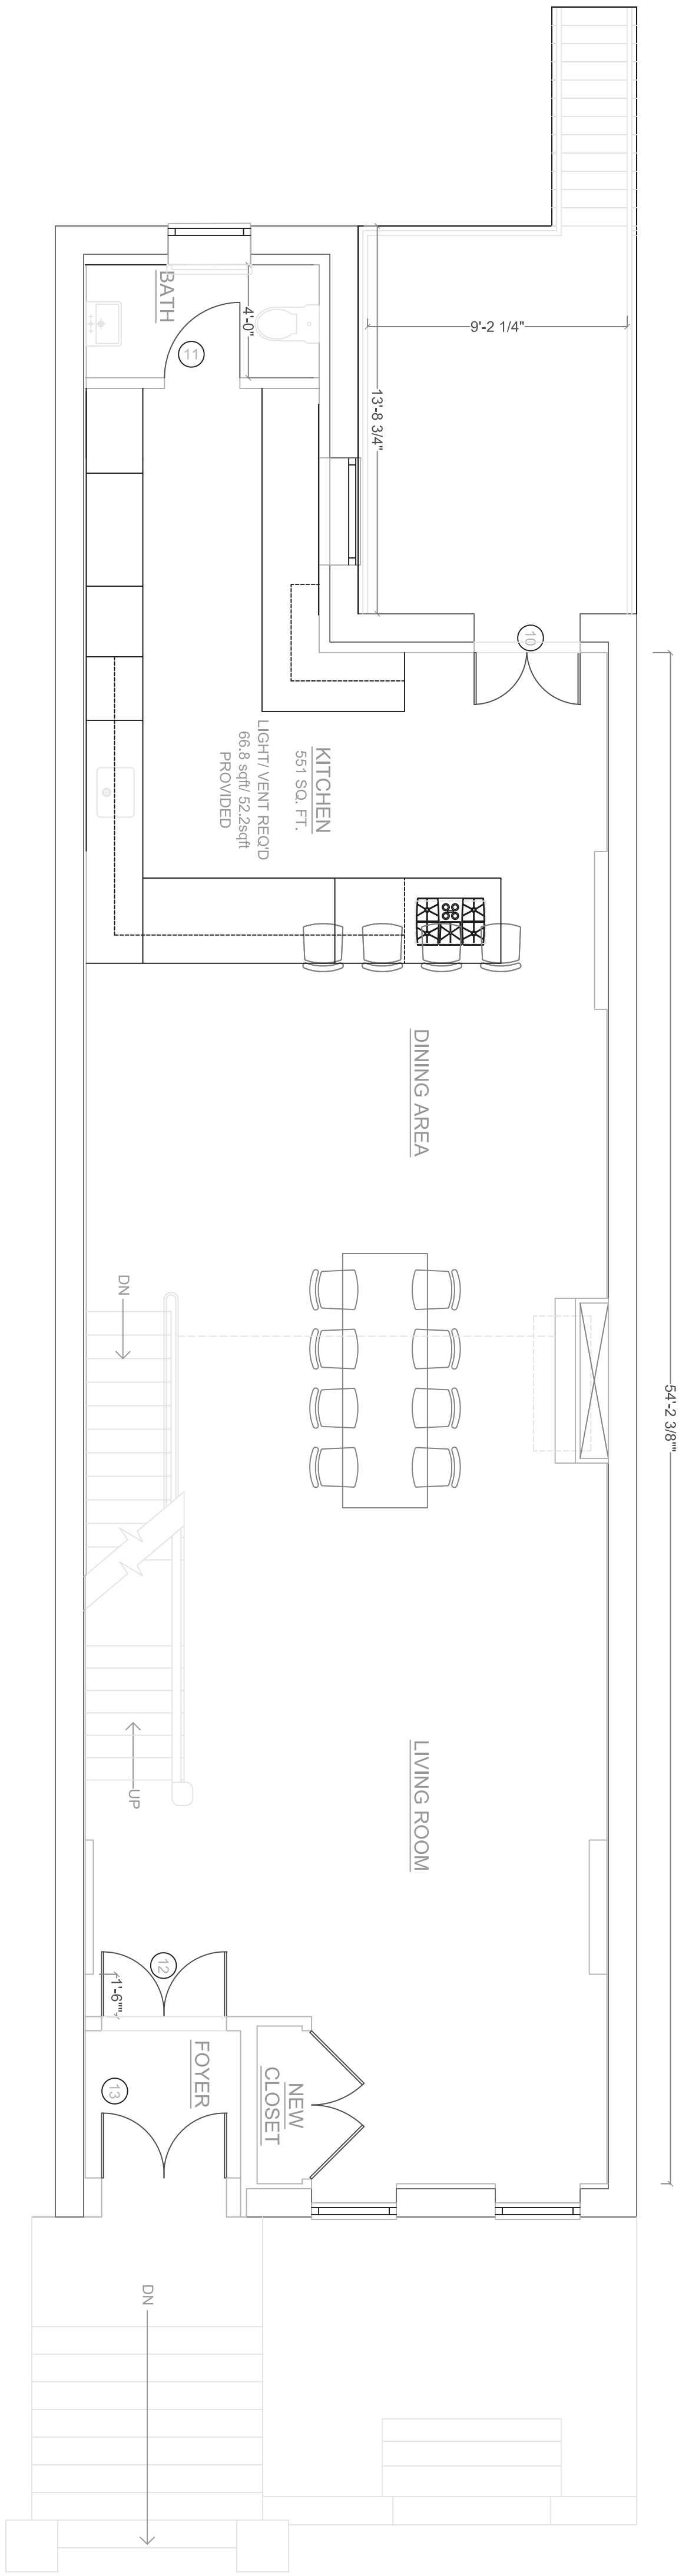


2 PARLOR OR THIRD FLOOR PLAN - MECHANICAL PLAN
SCALE: 1/8" = 1'-0"



NO.		DATE	REVISIONS
PROJECT			
154, WEST 73RD STREET NEW YORK, NY 10023			
RUSSELL GOSS, AIA LEED AP 1023 BROADWAY NEW YORK, NY 10010 P: 212.675.1659 F: 212.675.1659			
TITLE			
PARLOR & THIRD FLOOR PLAN - MECHANICAL PLAN			
DATE	TITLE	SCALE	
8.20.2012	MC-102.00	8'-0" = 1'-0"	

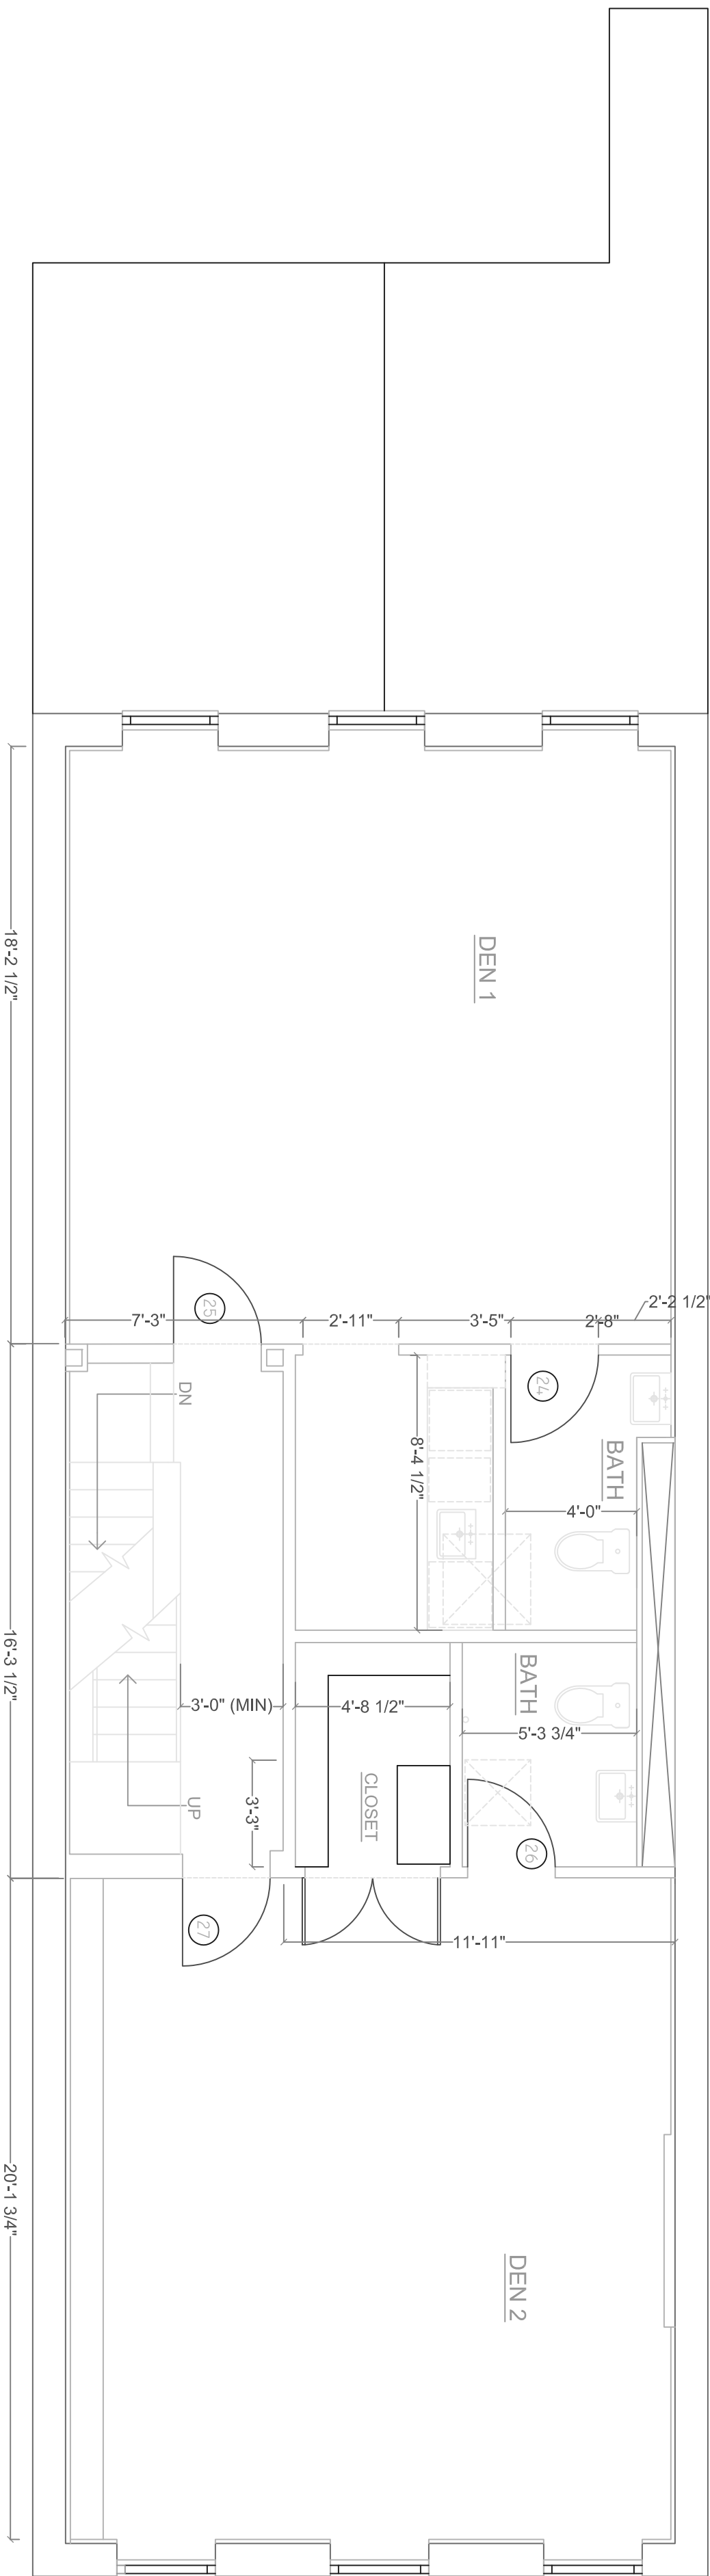


1 FIFTH FLOOR PLAN - MECHANICAL PLAN
SCALE: 1/8" = 1'-0"

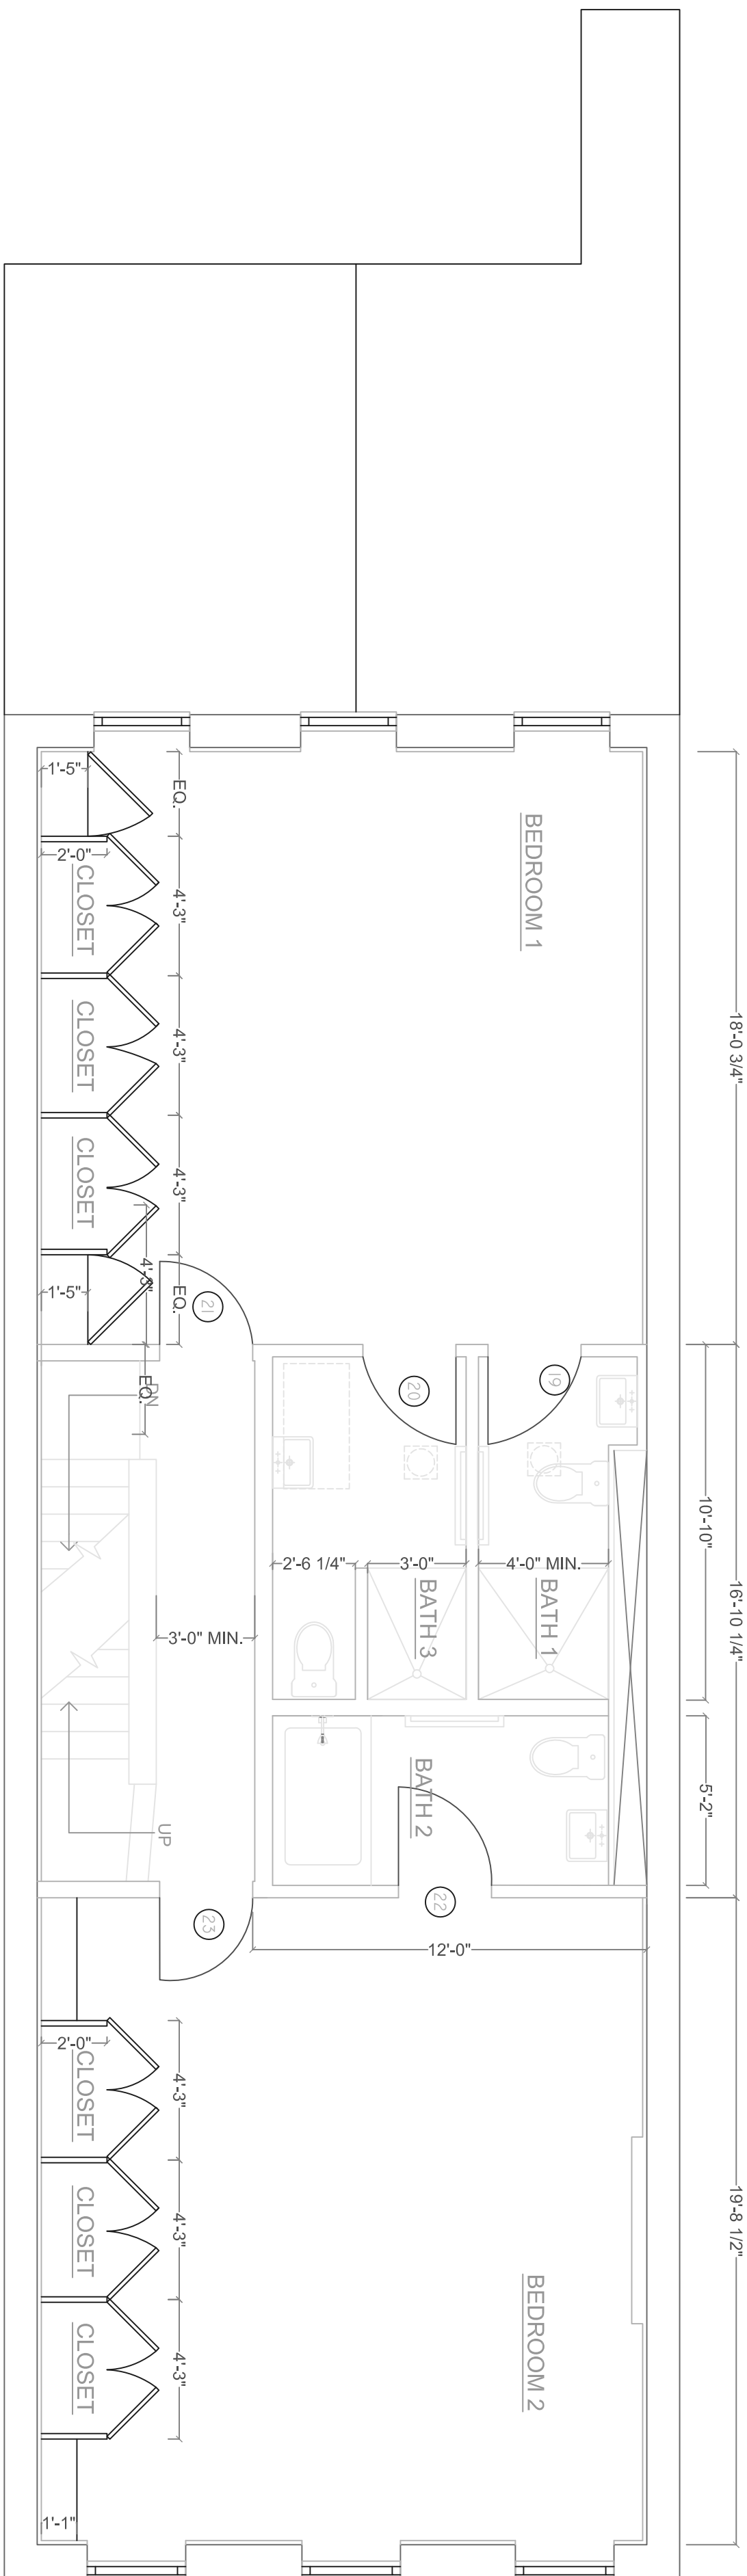

2 FOURTH FLOOR PLAN - MECHANICAL PLAN
SCALE: 1/8" = 1'-0"



NO.		DATE	REVISIONS
 RUSSELL GOSS, AIA LEED AP 1123 BROADWAY NEW YORK, NY 10003 P. 212.675.2658 F. 212.675.2659			
PROJECT 154, WEST 73RD STREET NEW YORK, NY 10023			
TITLE			
T.I.		9 OF 10	
DATE		MC-103.00	
8.20.2012			

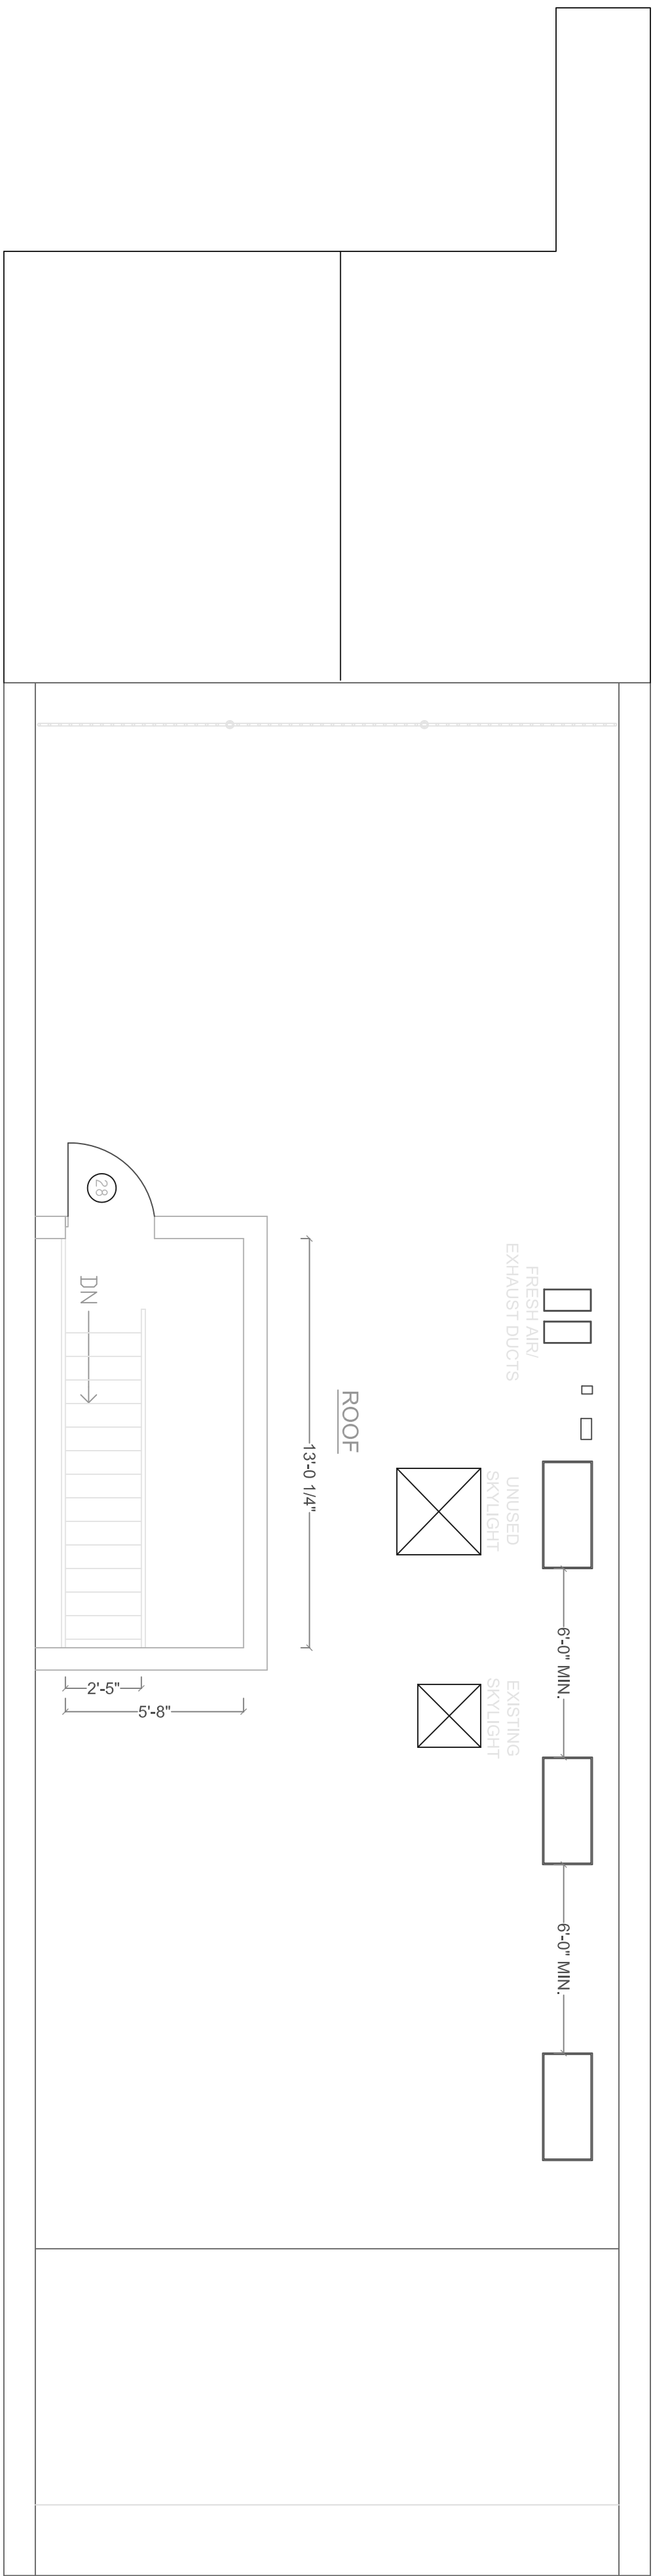

1 ROOF PLAN - MECHANICAL PLAN
SCALE: 1/4" = 1'-0"



NO.	DATE	REVISIONS



RUSSELL GOSS, AIA
LEED AP
1023 BROADWAY
NEW YORK, NY 10010
P. 212.675.2658
F. 212.675.2659

PROJECT
154 WEST 73RD STREET
NEW YORK, NY 10023

TITLE
ROOF PLAN -
MECHANICAL PLAN/
DETAIL

REV.	DATE	BY	10 OF 10
1	8.20.2012	T.T.	MC-104.00