




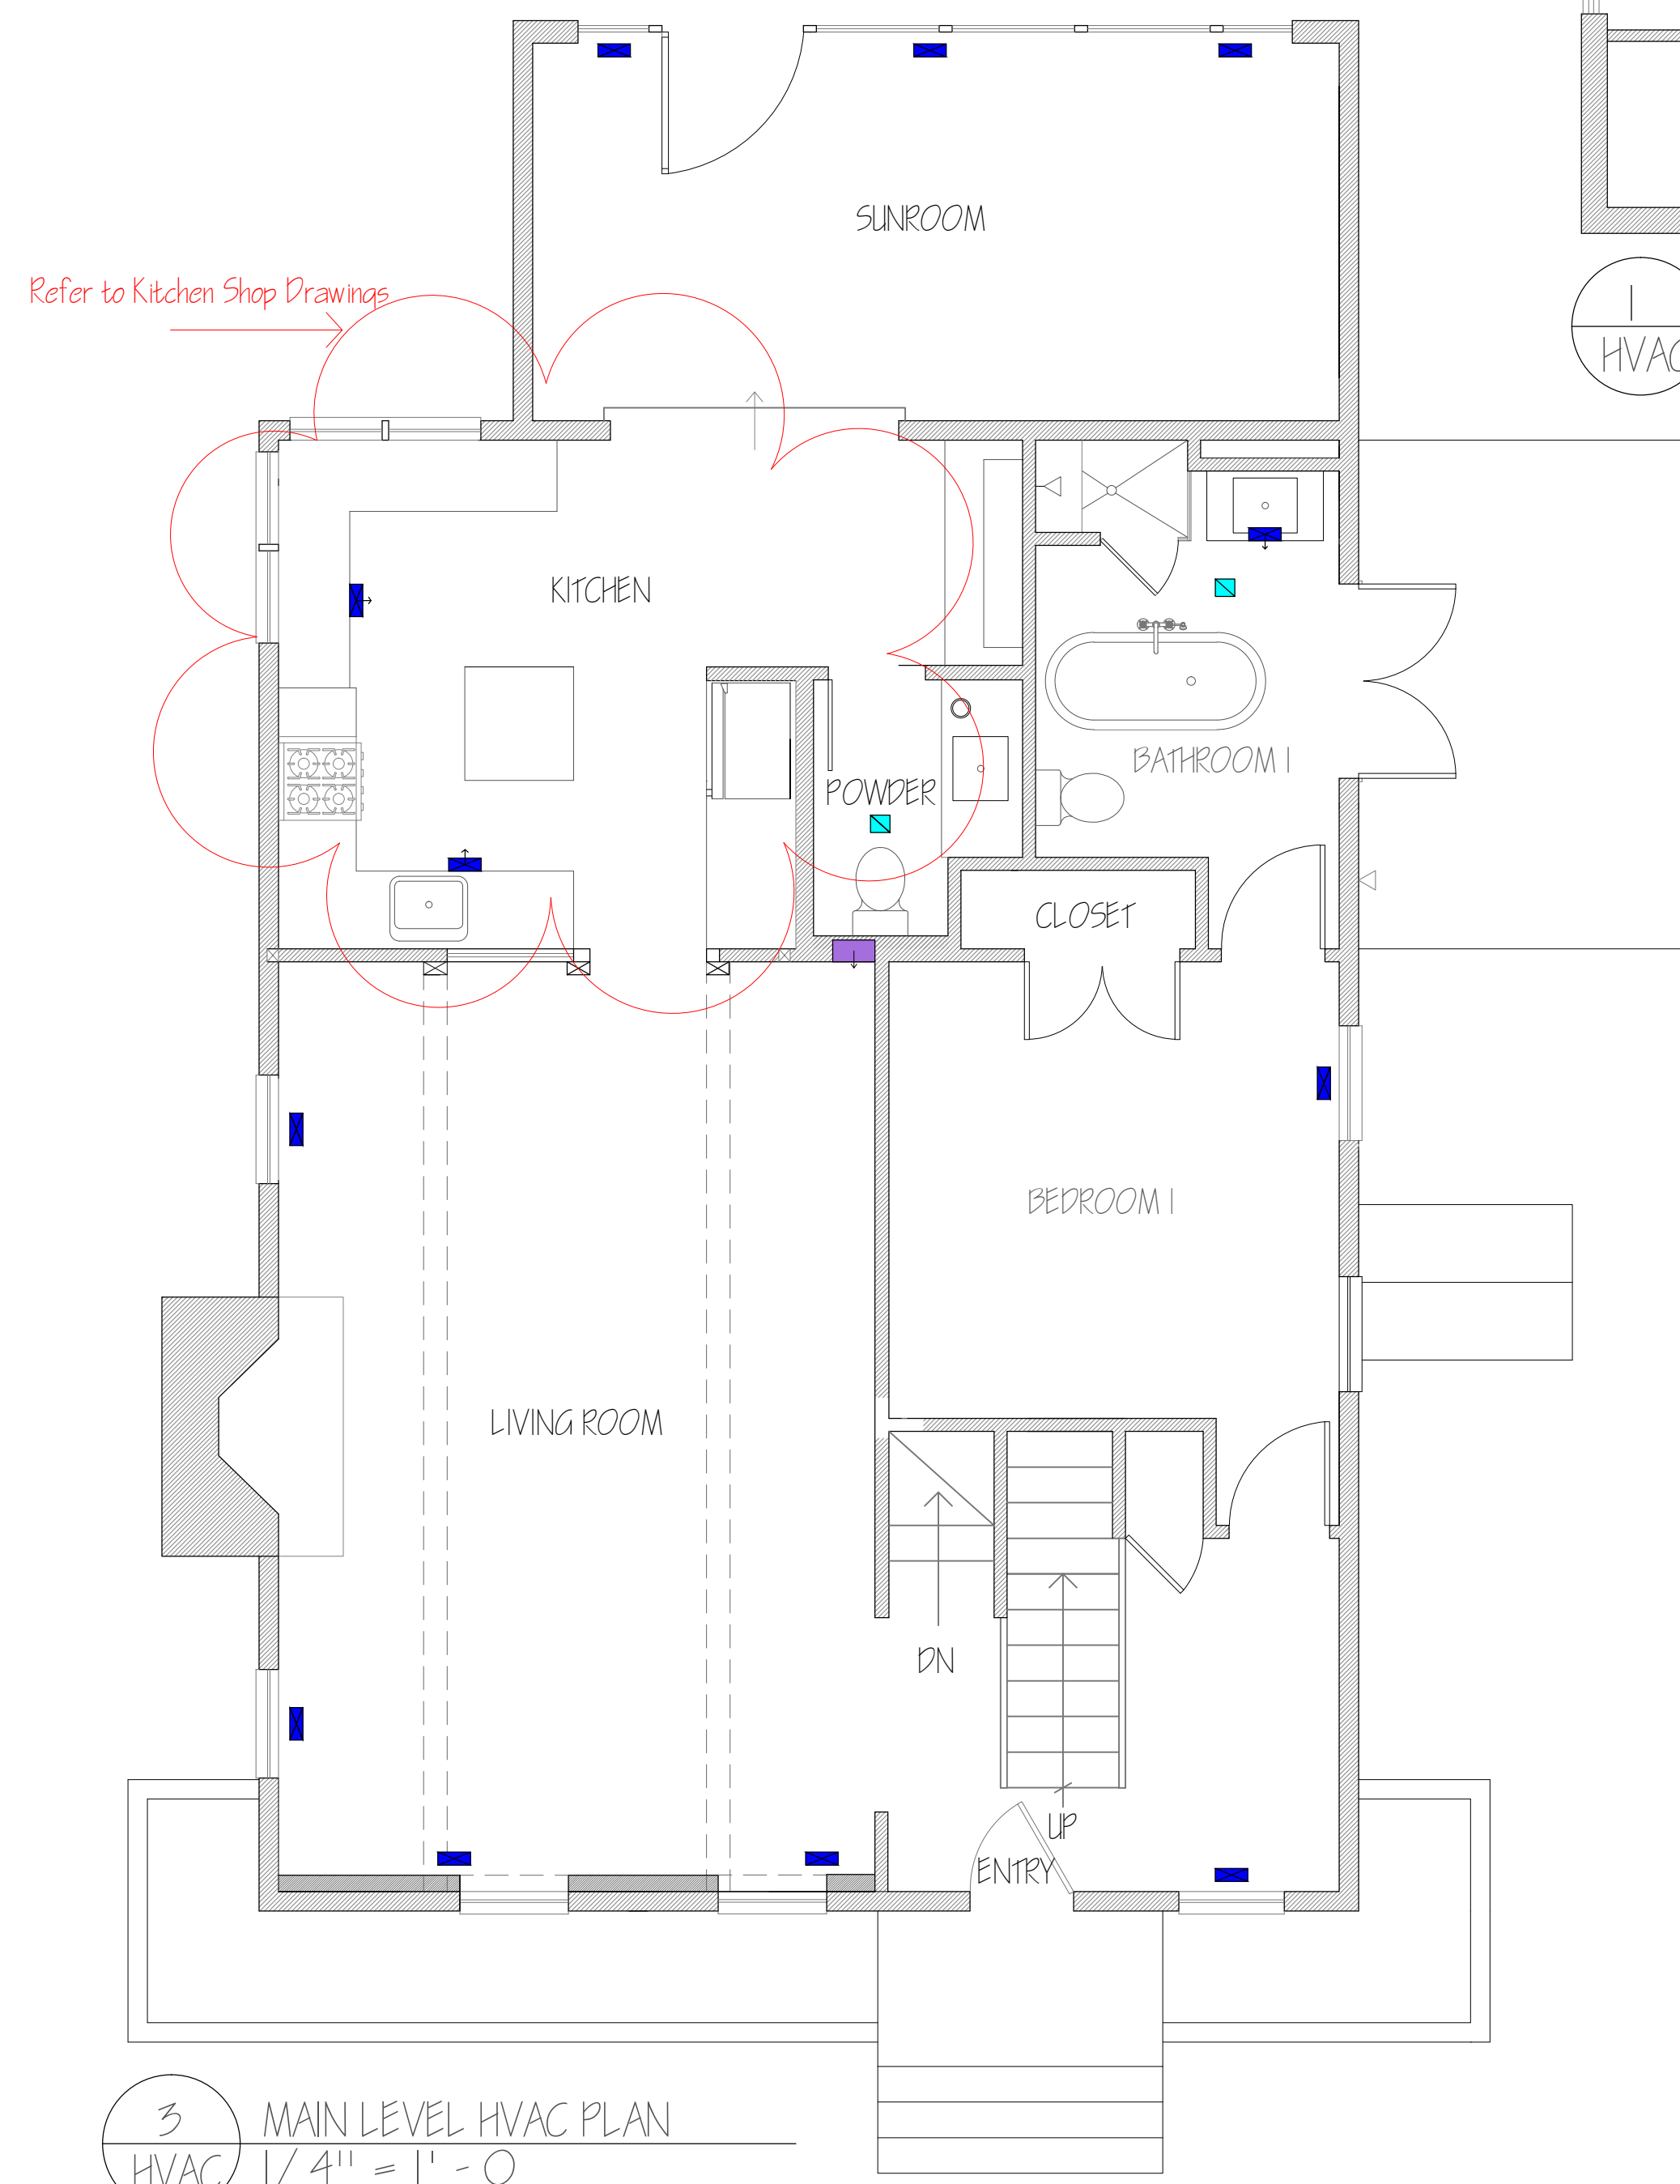


3 MAIN LEVEL HVAC PLAN
1/4" = 1' - 0"

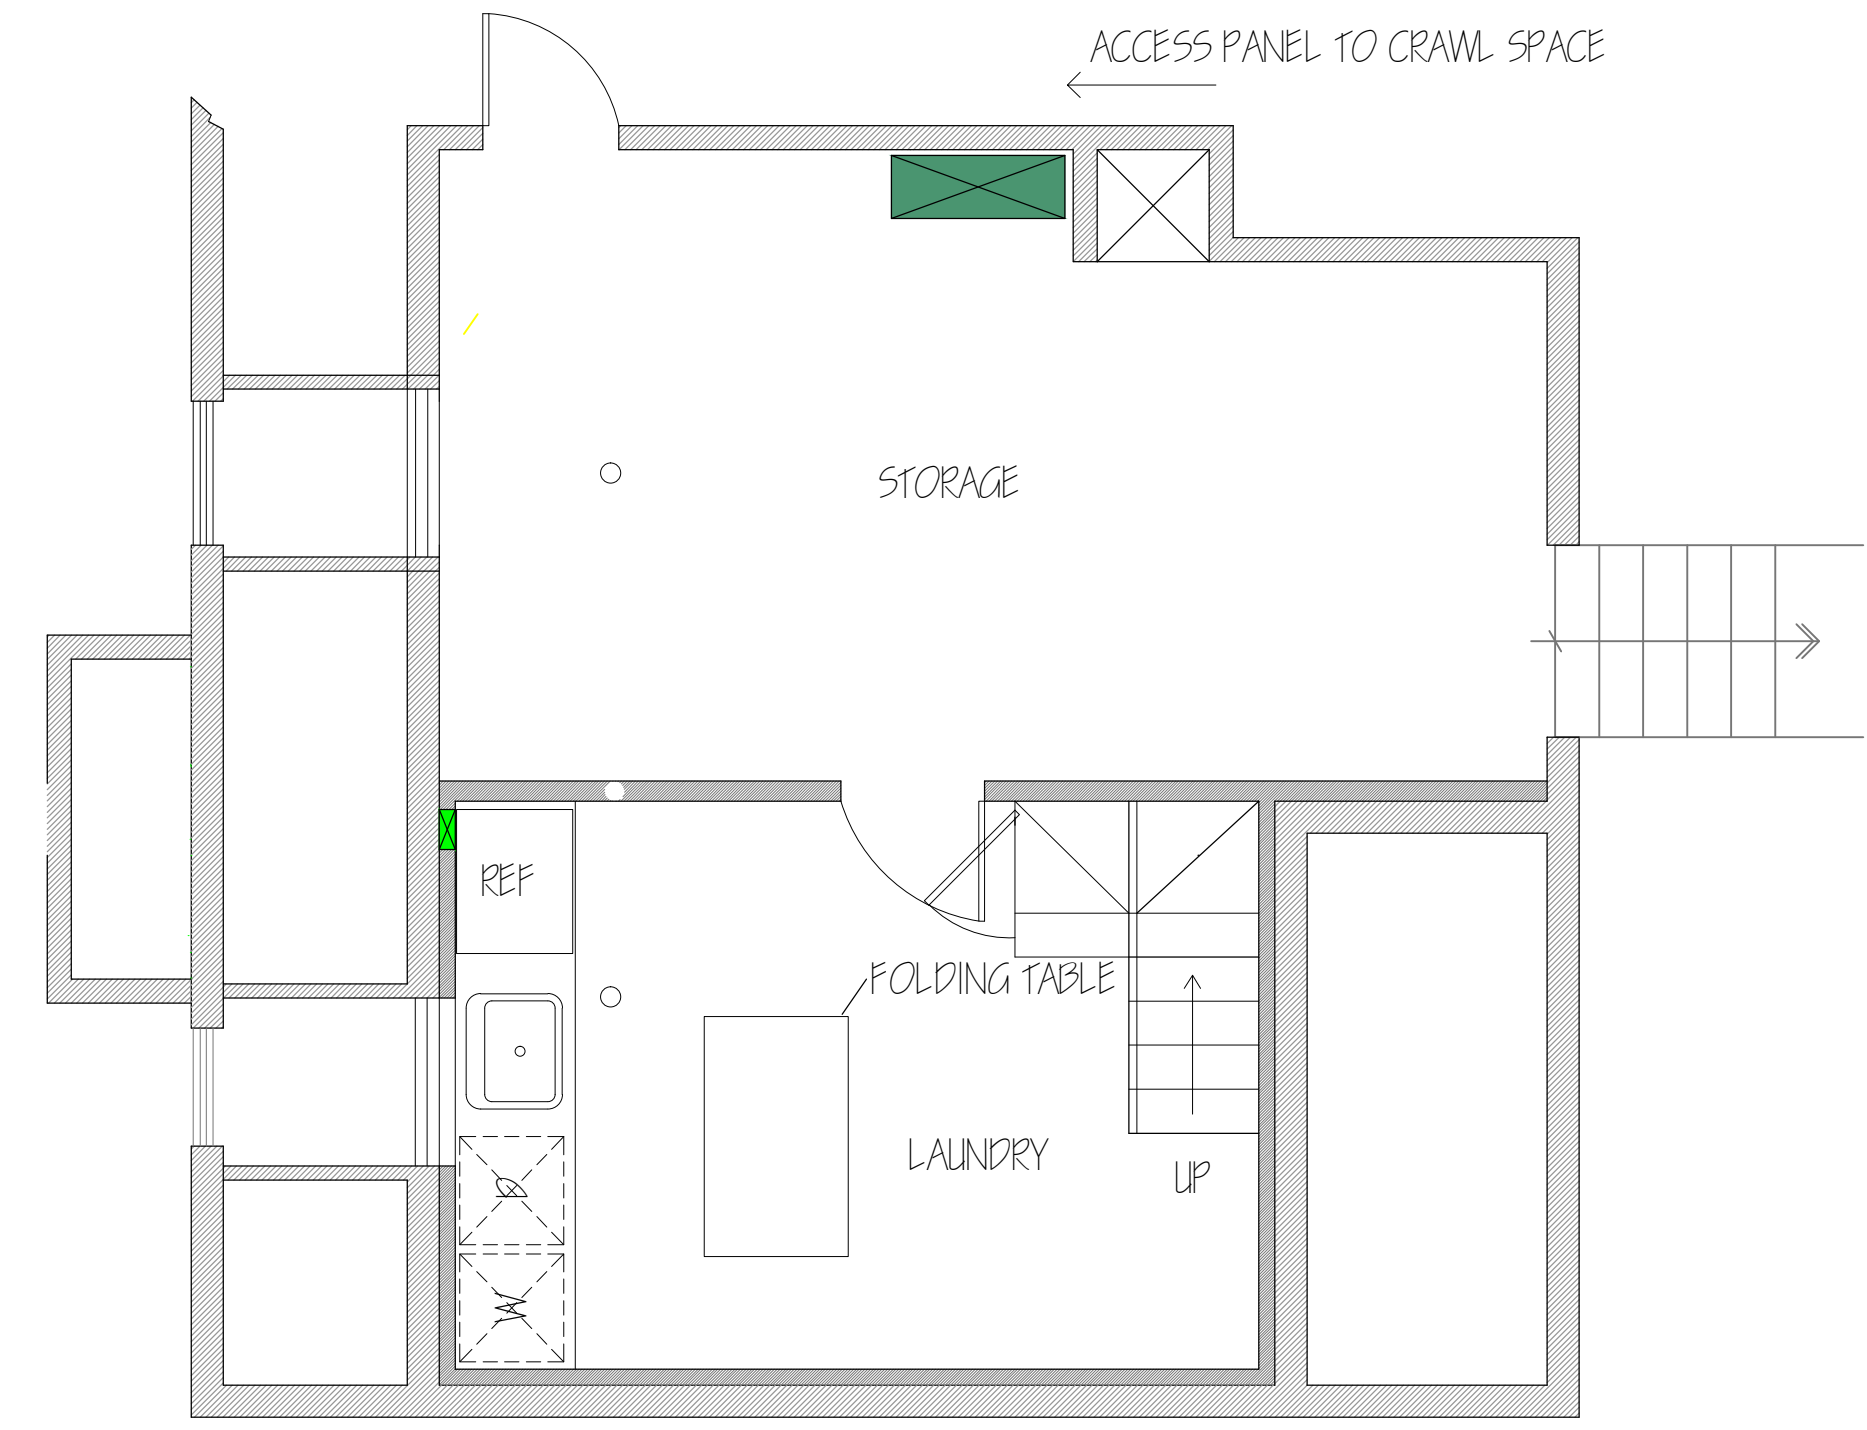

1 CELLAR HVAC PLAN
1/4" = 1' - 0"

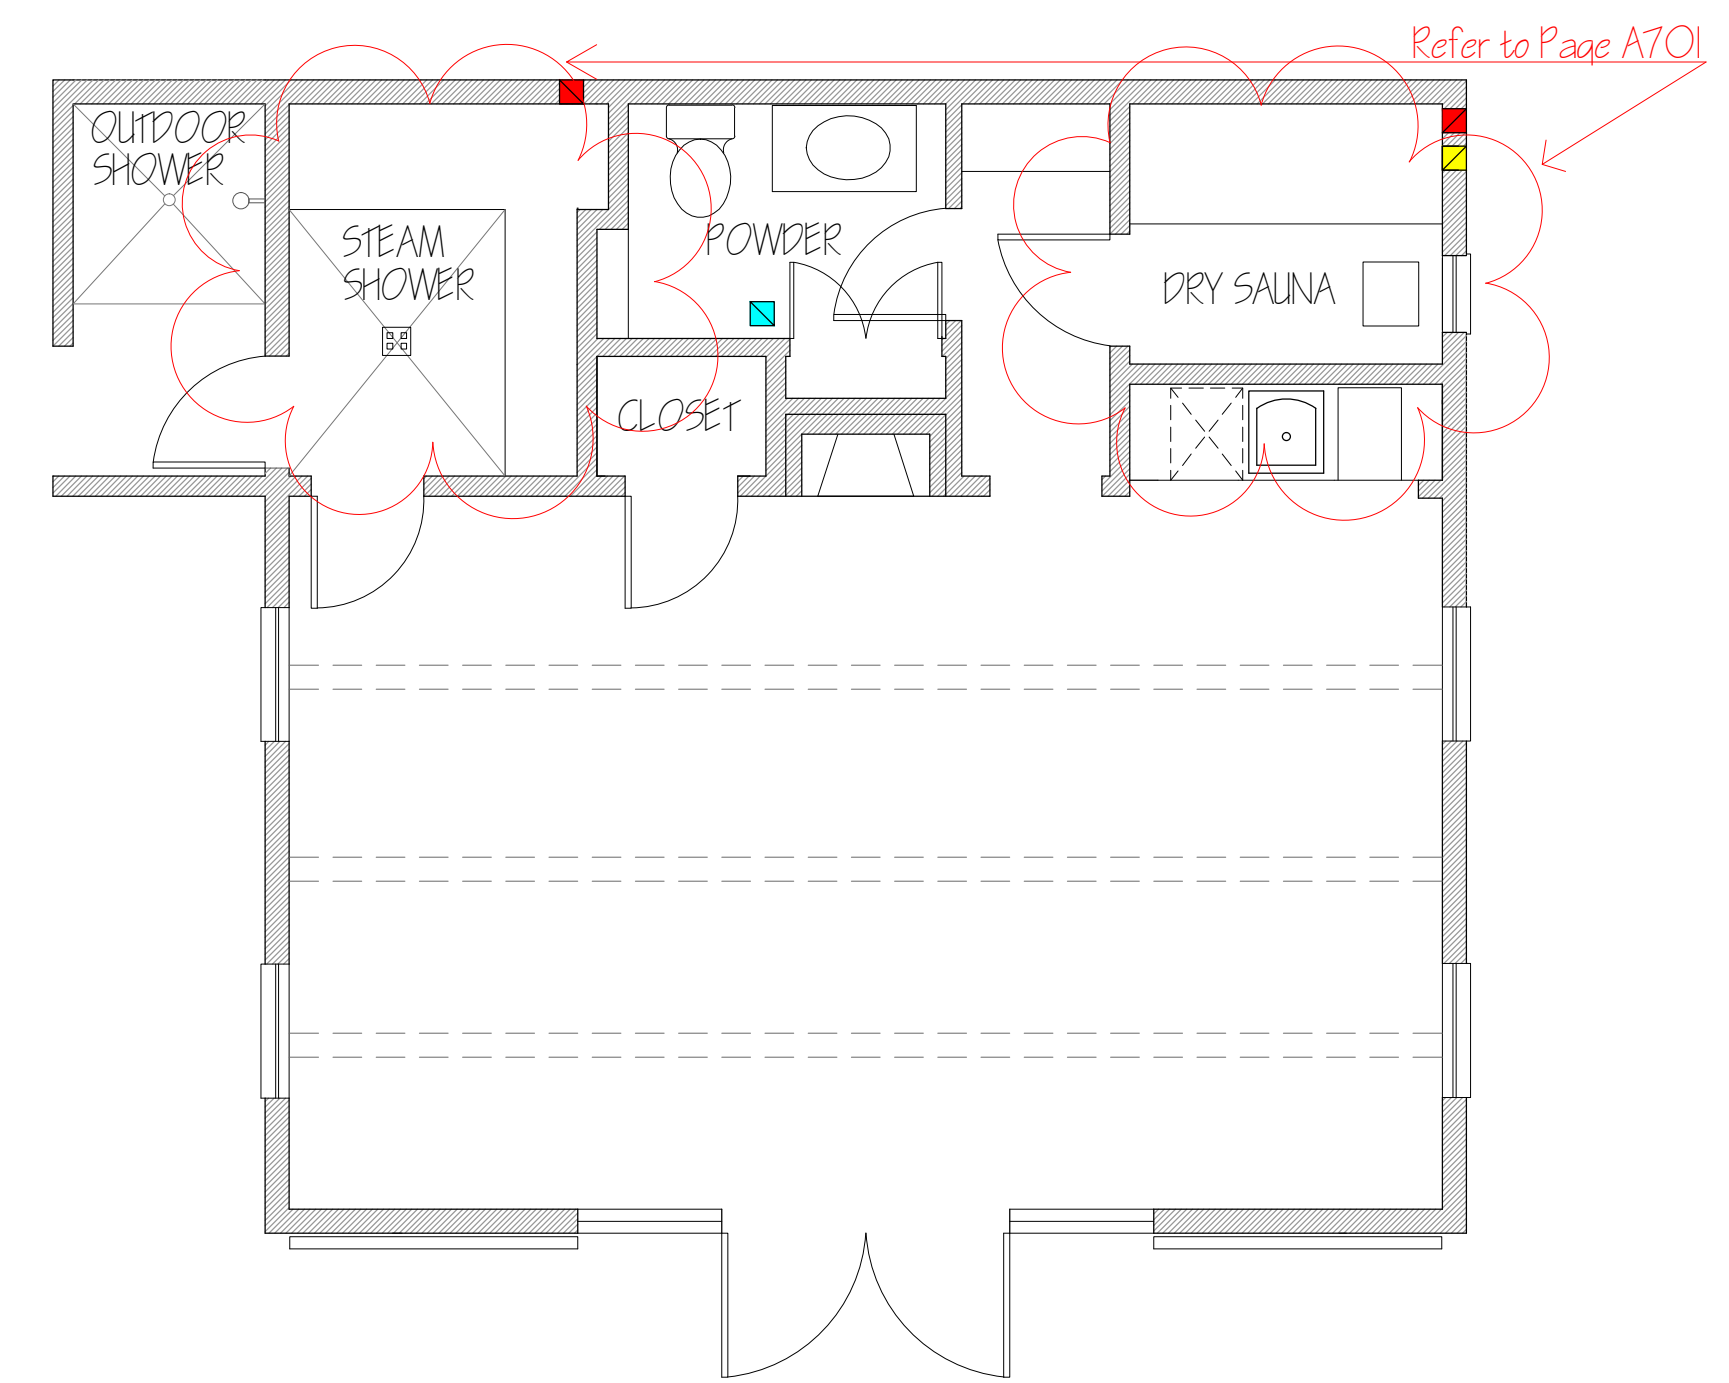


2 SPA HVAC PLAN
1/4" = 1' - 0"

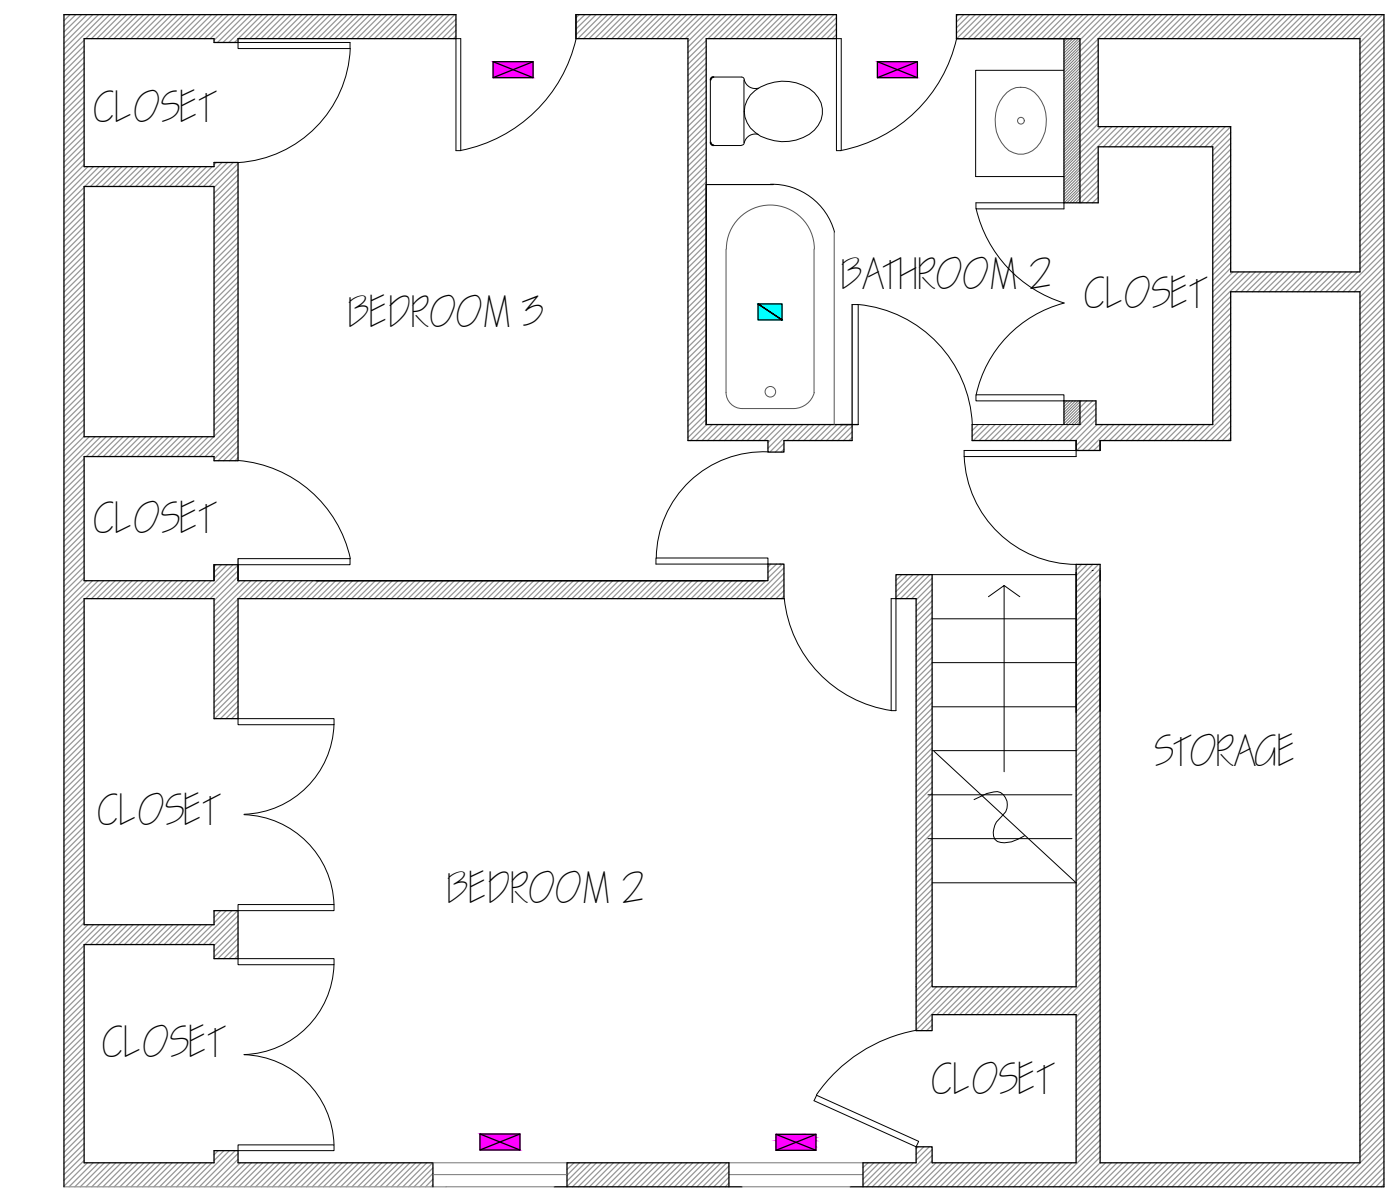

4 SECOND LEVEL HVAC PLAN
1/4" = 1' - 0"

- HVAC Legend
- Wall Register
 - Floor Register
 - Ceiling Register
 - High Vent
 - Electric Exhaust Vent
 - Low Vent
 - Possible Return Register
 - Boiler

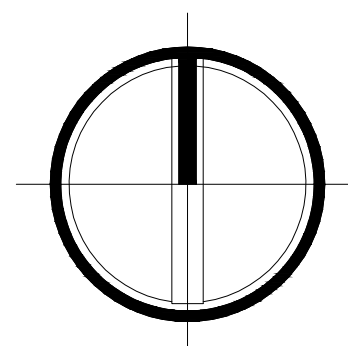

8 ACKERLY

DRAWING TITLE:
HVAC PLAN

DATE:
1.2015

SCALE:
1/4" = 1' - 0"

DRAWN BY:
BG

HVAC

HEIBERG CUMMINGS DESIGN
655 WASHINGTON STREET
NEW YORK, NEW YORK 10014
212-337-2030 P
212-337-2033 F