
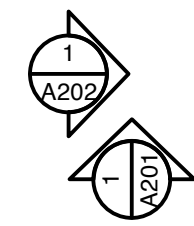


Electrical Legend	
	Single Pole Switch
	Single Pole Switch With Dimmer
	Three Way Switch
	Duplex Receptacle Outlet
	Duplex Receptacle Switched Outlet
	220 V Receptacle Outlet
	GFI Duplex Receptacle Outlet
	Weatherproof Duplex Receptacle Outlet
	Duplex Receptacle Floor Outlet
	Waterproof Ceiling Fixture
	Recessed Ceiling Fixture
	Surface Mounted Ceiling Fixture
	Surface Mounted Box for Hanging Pendant
	Cabinet Fixture
	Wall Mounted Fixture
	Waterproof Wall Mounted Fixture
	Telephone Jack
	TV Jack
	Computer Network Jack
	Thermostat
	Smoke Detector
	Carbon Monoxide Detector
	Alarm Key Pad
	Floor Mounted Up-Light

NOTES: BASEMENT ONLY)

1. Bathroom tile to be 3x6 machine made subway tile shower wall and 12 x 24 porcelain tile floor
2. Fixtures to be Toto Ultramax toilet and Restoration Hardware by owner
3. Cabinetry in AV room and Game room to be full ht painted wood
4. Cabinetry in laundry room to be laminate lowers, uppers and formica top. Sink and fixture by owner.
5. Egress windows to be Andersen push out dbl casements

NOTE:
ALL DIMENSIONS ARE +/- ORIGINAL AS-BUILTS PREPARED WHILE THE SPACE WAS OCCUPIED. IF THERE ARE ANY CONFLICTS OR ADJUSTMENTS REQUIRED PLEASE NOTIFY ARCHITECT.

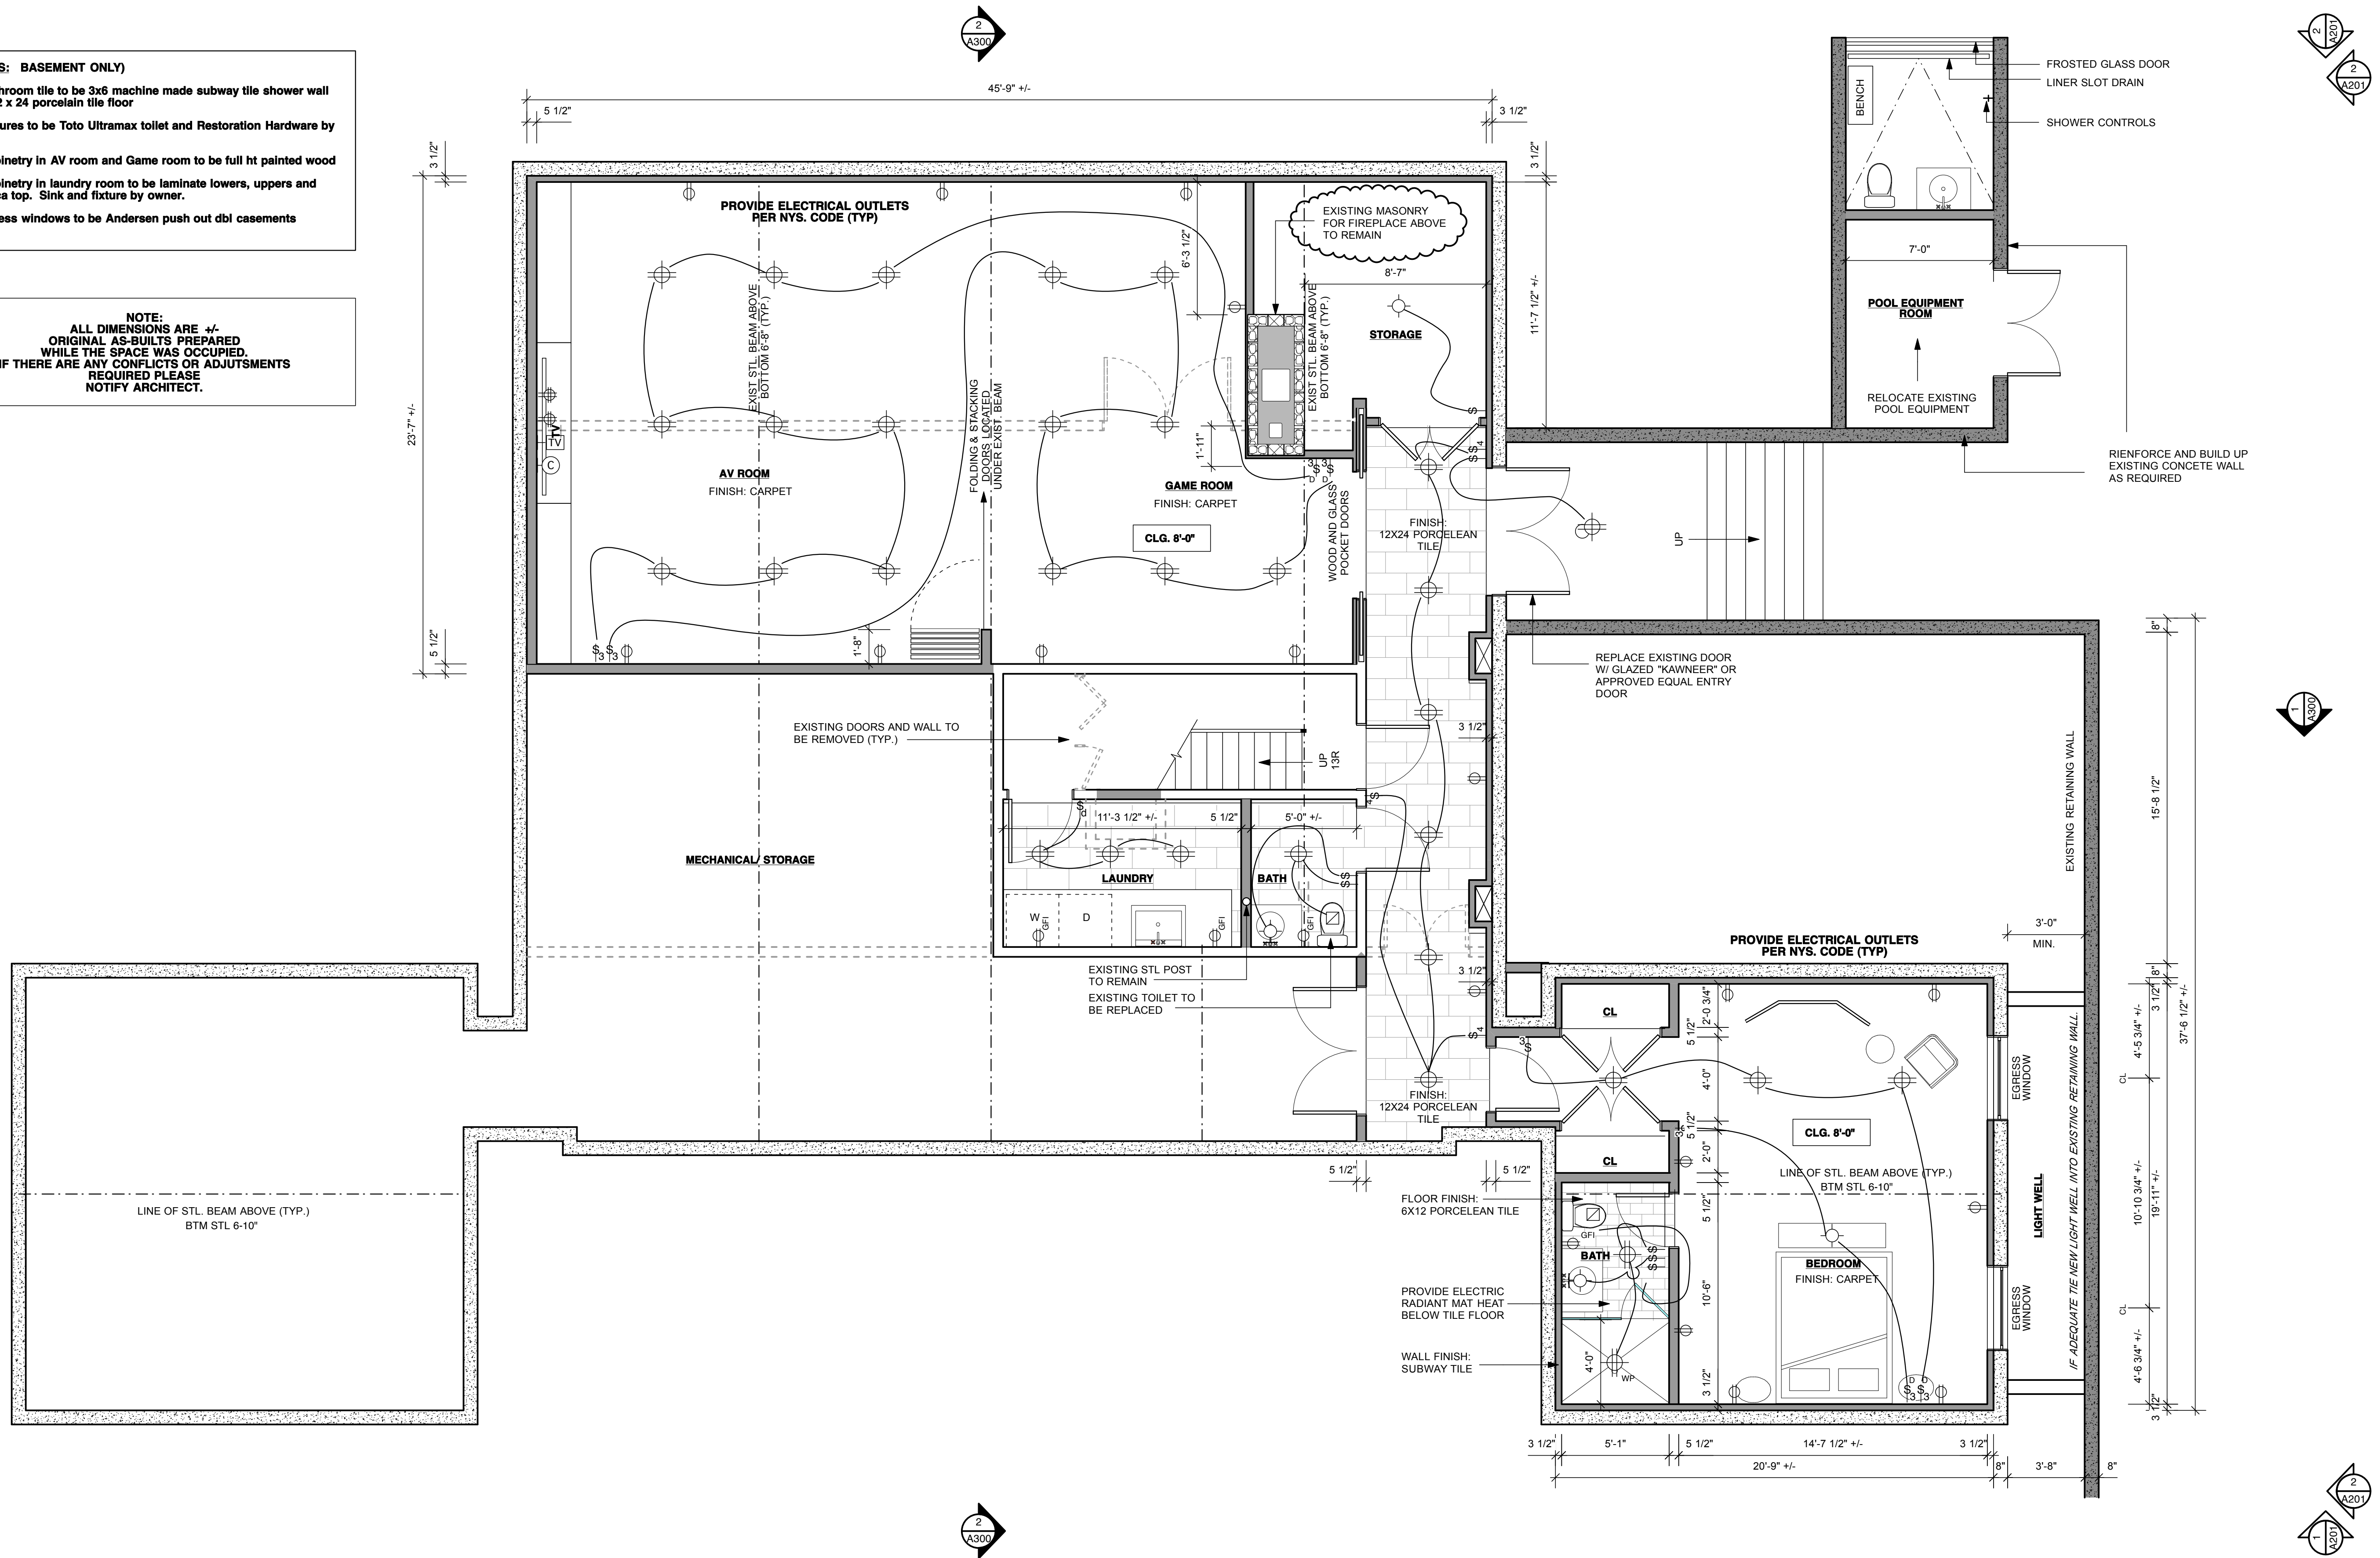

Bayview Road • Sag Harbor, NY 11963
ph 917.449.7505 • fax 631.614.4250
nadams@nicoleadamsstudio.com

THIS PROJECT SHALL COMPLY WITH THE 2010 MECHANICAL CODE OF NY STATE, CHAPTERS 12 THROUGH 24, THE PLUMBING CODE OF NY STATE, CHAPTERS 25 THROUGH 32, & THE ELECTRICAL CODE OF NY STATE, CHAPTERS 33 THROUGH 42

Issued:
1. Existing Conditions 3.27.2014

Drawing Legend:	
	Wall To Be Removed
	Wall To Remain
	New Wall
	New Foundation Wall
	Lines Above
	Lines Below
	Guidelines
	Fence
	Door Tag
	Window Tag
	Section X, Sheet A-XXX
	Detail Tag
	Elevation Tag

John Cronin PE
2 Ward Rd P.O. Box 130
Shelter Island, NY 11964-0130
ph 631.282.1167
E-Mail: ceptjccpe@optimum.net

Mecox Road Residence
Scale: 1/4"=1'-0"
Note: If Drawing is Printed On 11x17 Paper Scale is 30% Scale Above
Date: 03/14/2014
BASEMENT PLAN.
PLAN

A100